



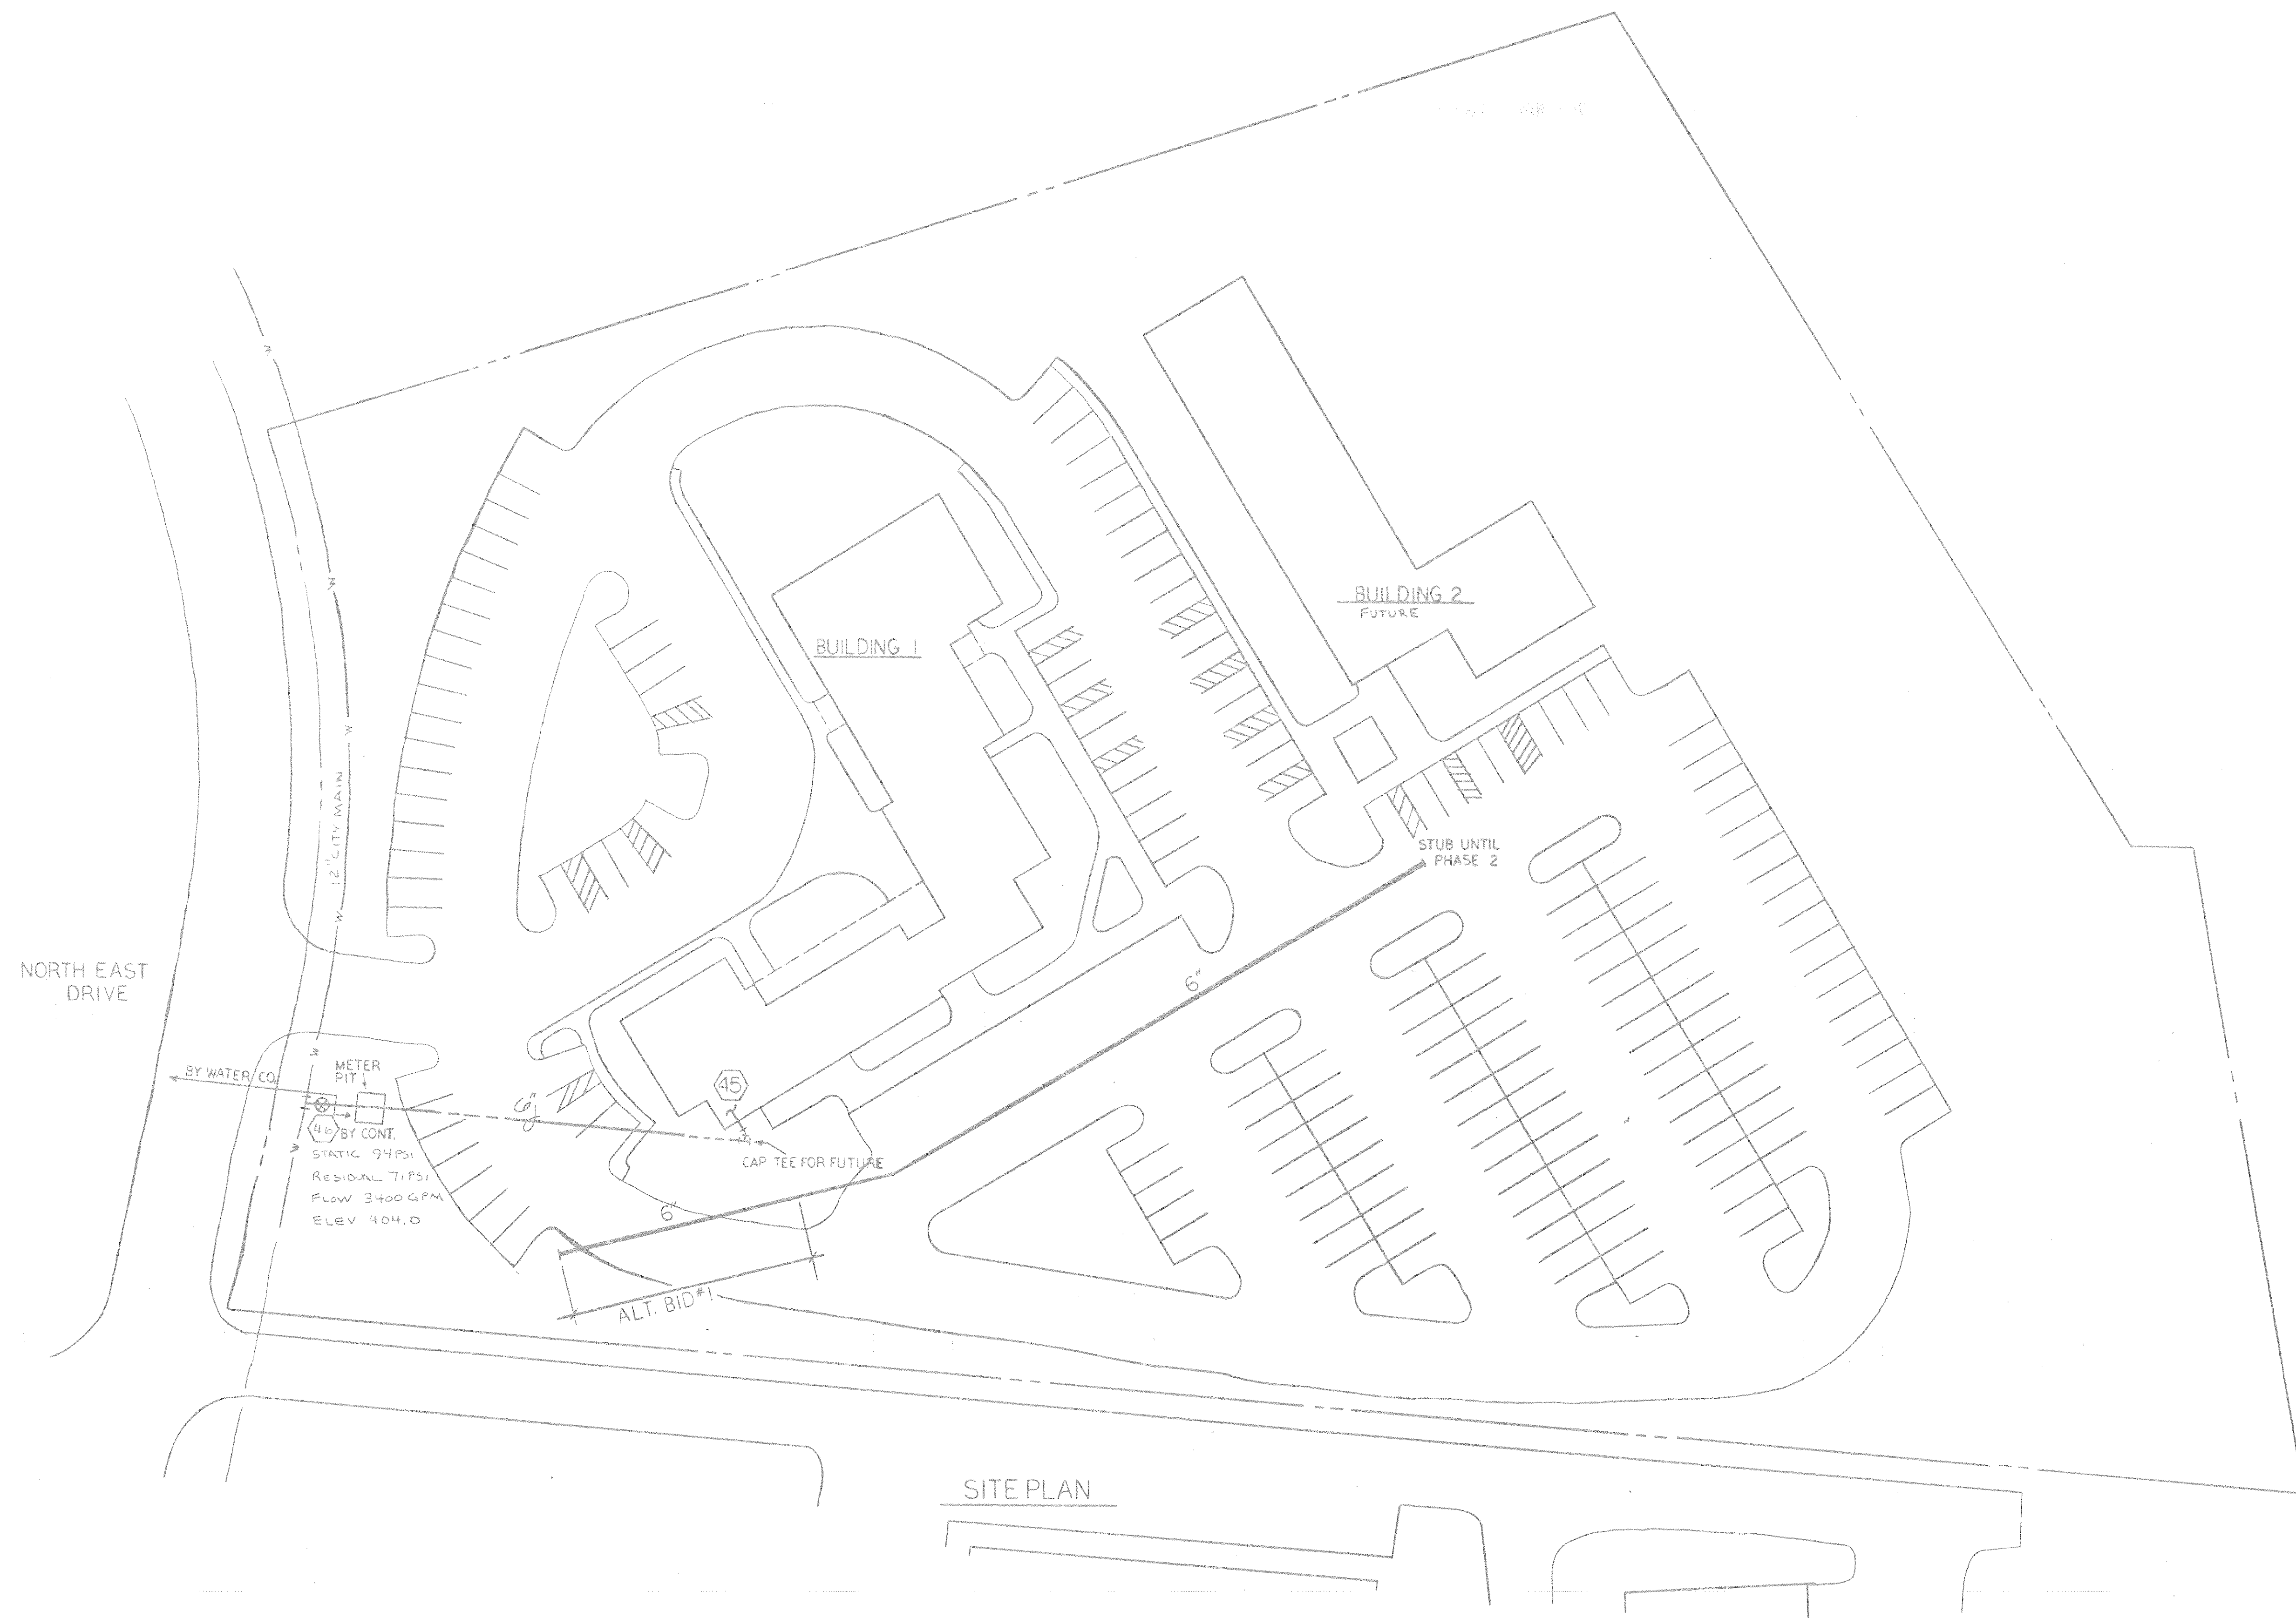


SITE PLAN

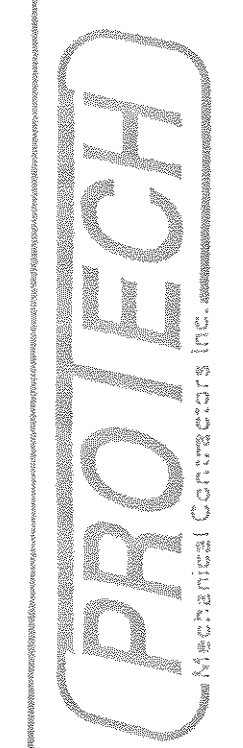

104 E. Prospect Road
Columbia, PA 17512
(717) 684-9050
FAX (717) 684-2595


SPRINKLER PLAN
PHYSORT HORAD

FP-1

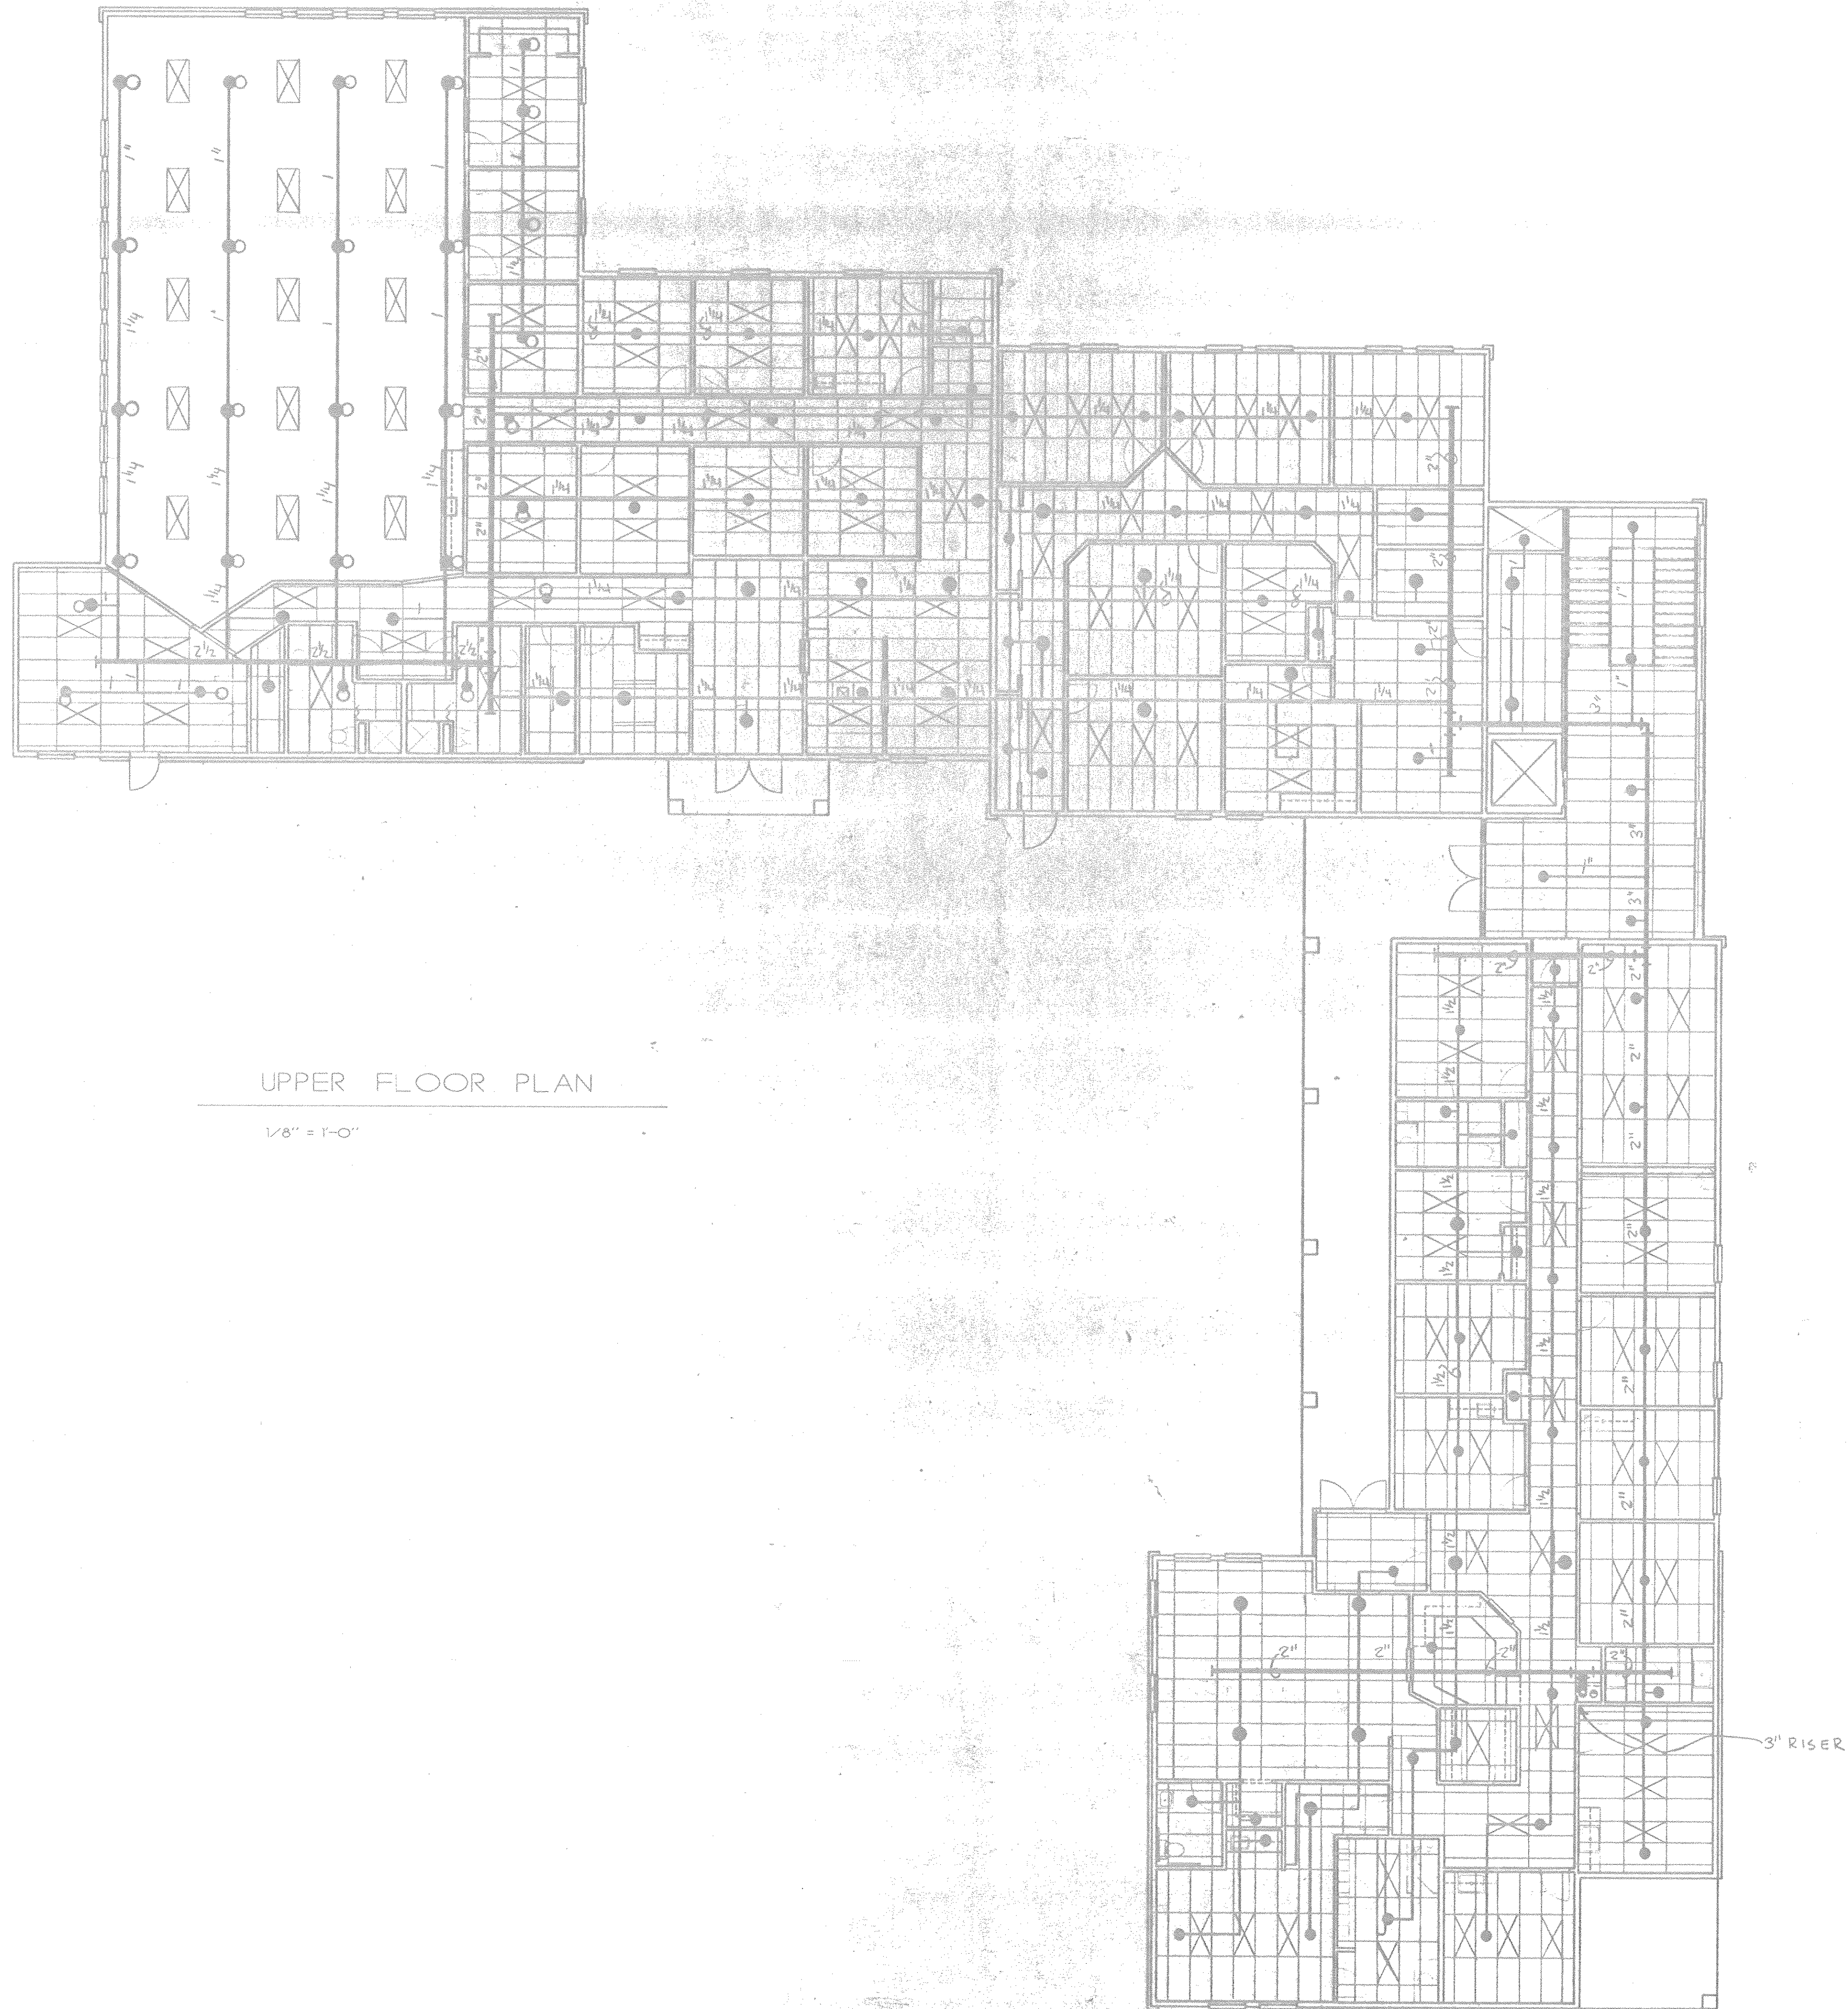


UPPER FLOOR PLAN

1/8" = 1'-0"

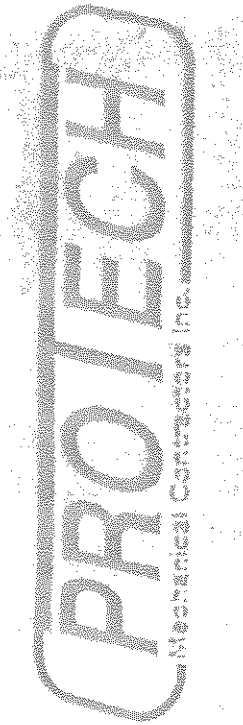

104 E. Prospect Road
Columbia, PA 17312
TEL: (717) 654-9050
FAX: (717) 654-2555

Bradley, Chambers,
& Frey, Inc.
Architecture, Planning & Design
P.O. Box 1227 / 38 N. Christian St. / Lancaster, PA 17603
TEL: (717) 291-1155 / FAX: (717) 291-1155

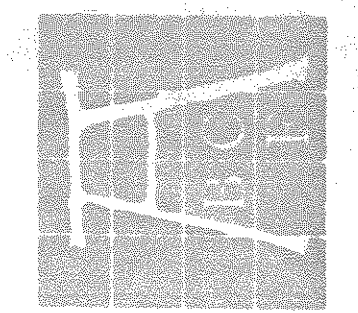


DATE
REVISIONS

DRAWN BY
PROJECT NUMBER

SPRINKLER PLAN
UPPER FLOOR

DRAWING NUMBER


FP-3

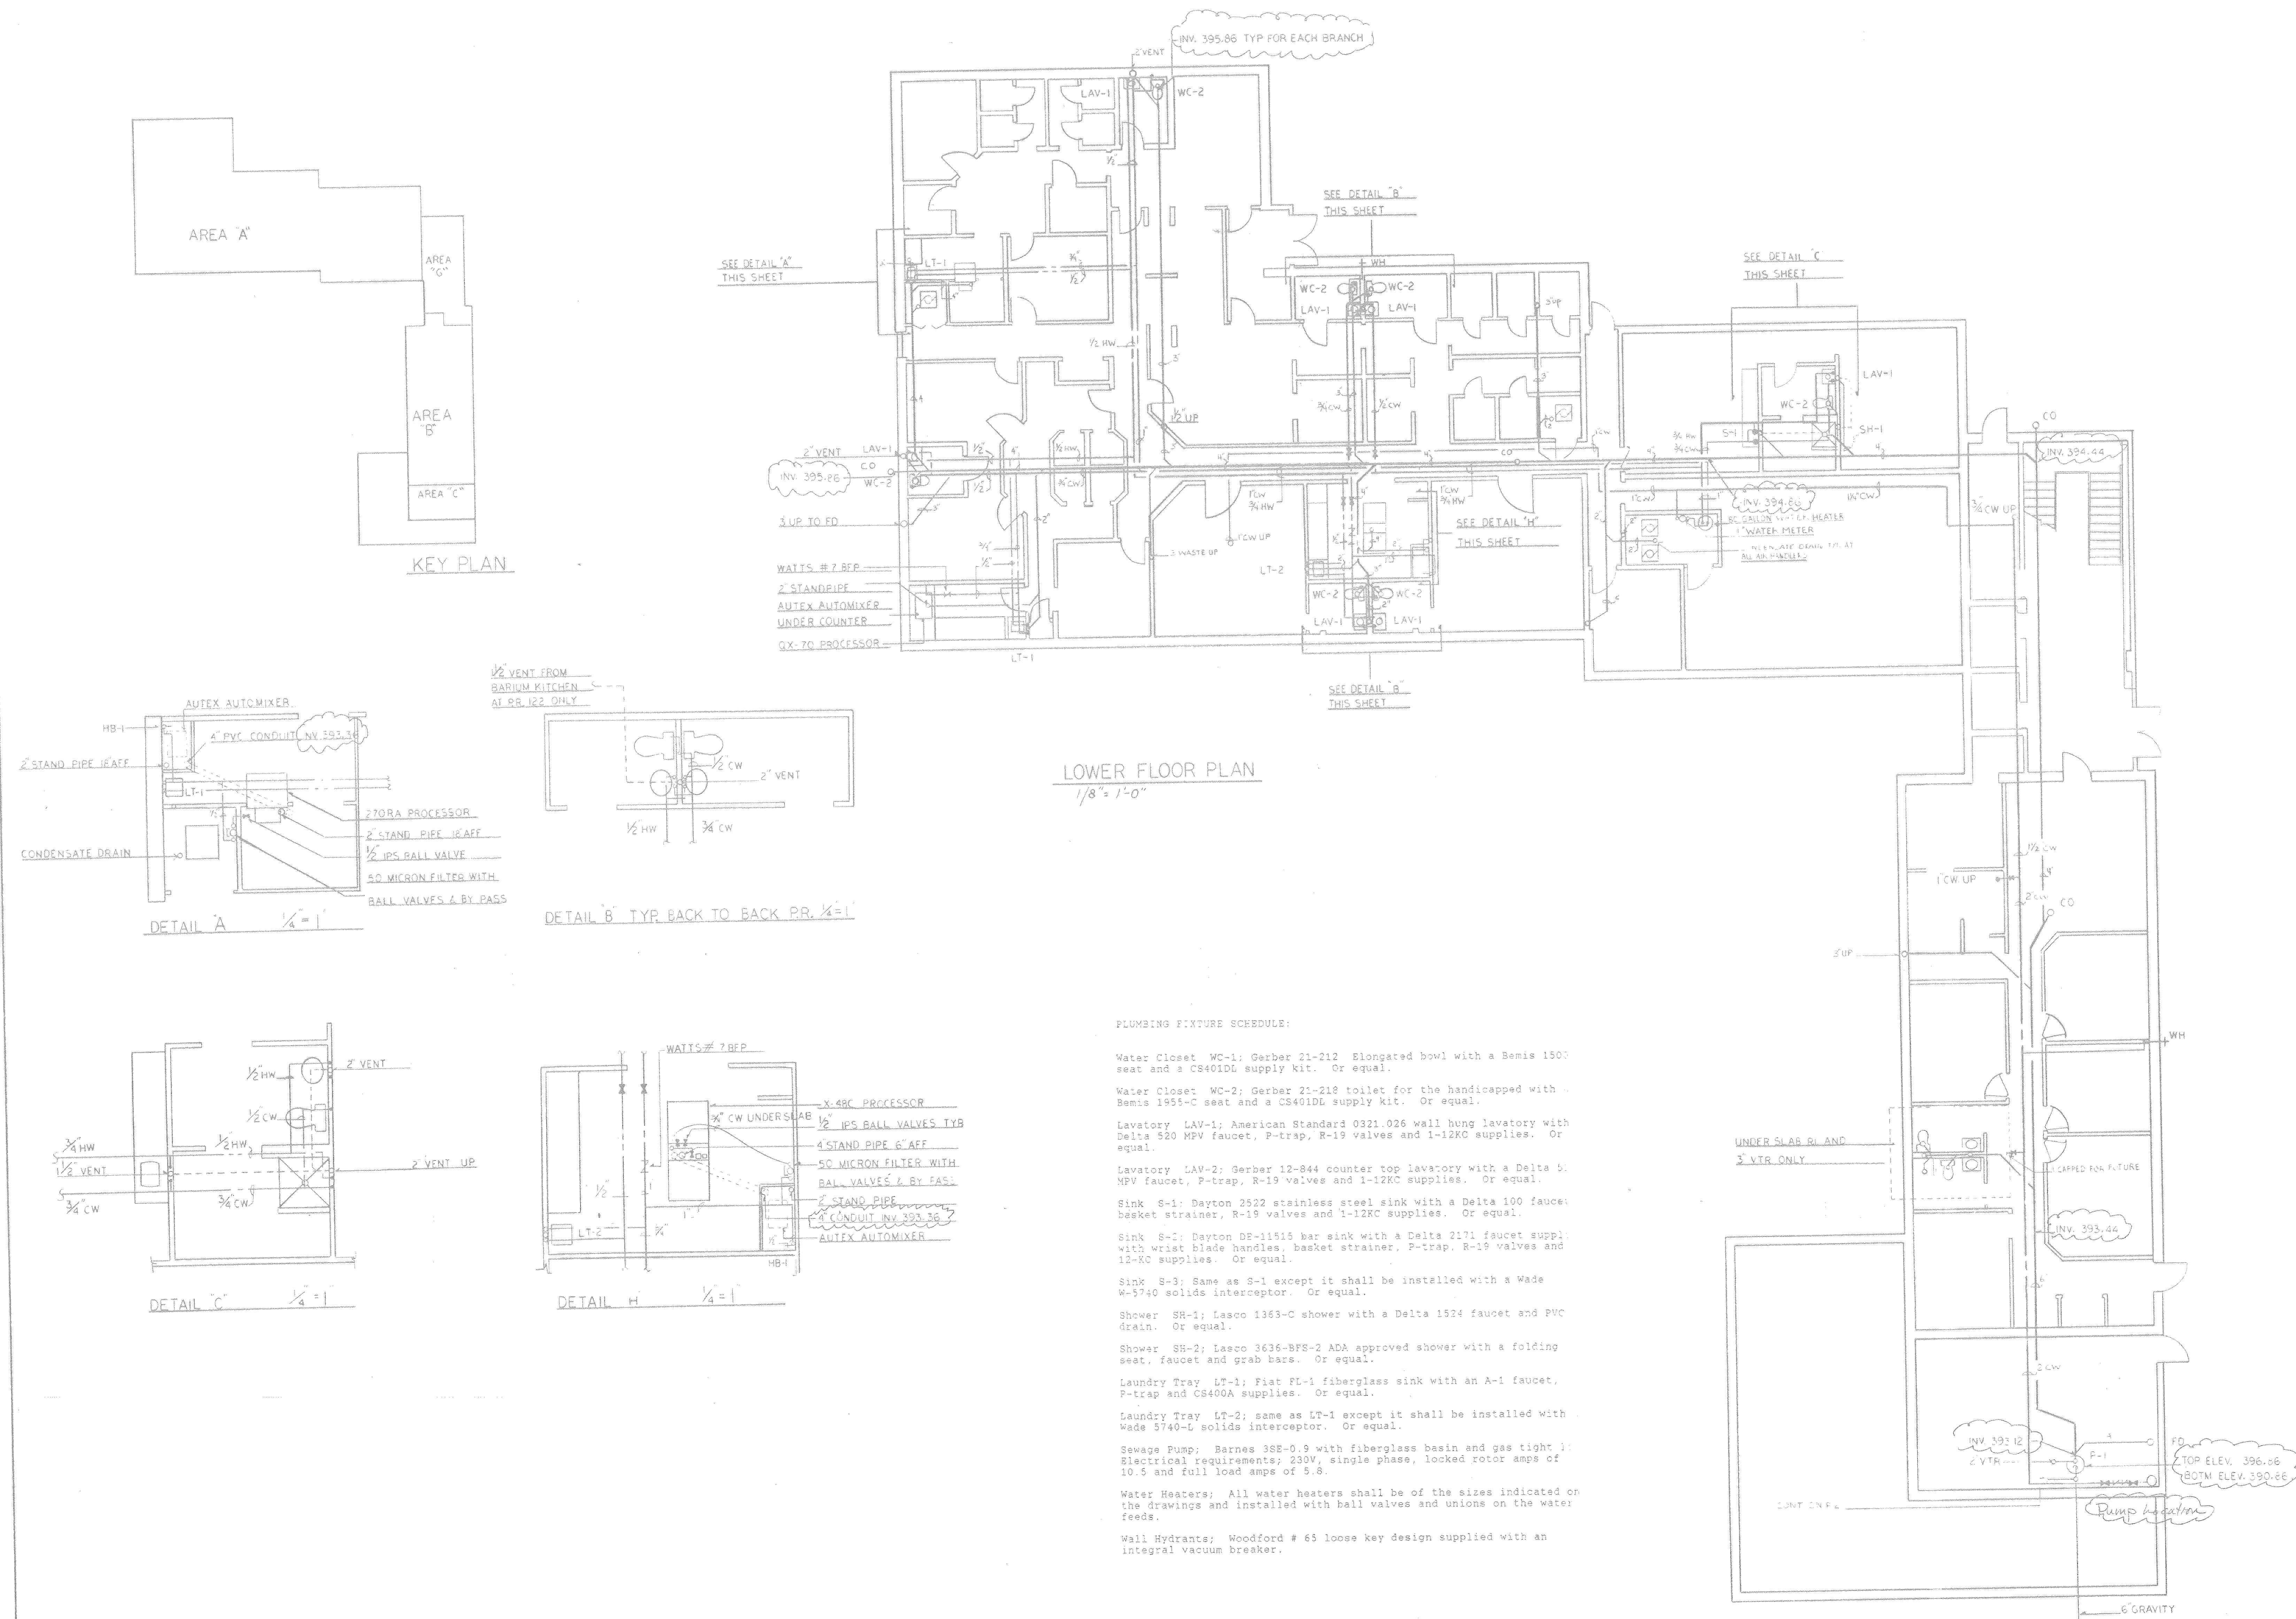

REVISIONS	
NO.	DATE
1	6-5-93

PROTECH
Mechanical Contractors Inc.
104 E. Prospect Road
Columbia, PA 17312
(717) 684-9050
FAX (717) 684-2995


NEW MEDICAL OFFICES
FOR
PHYSIOTHERAPY ASSO.
LOWER FLOOR
PLAN

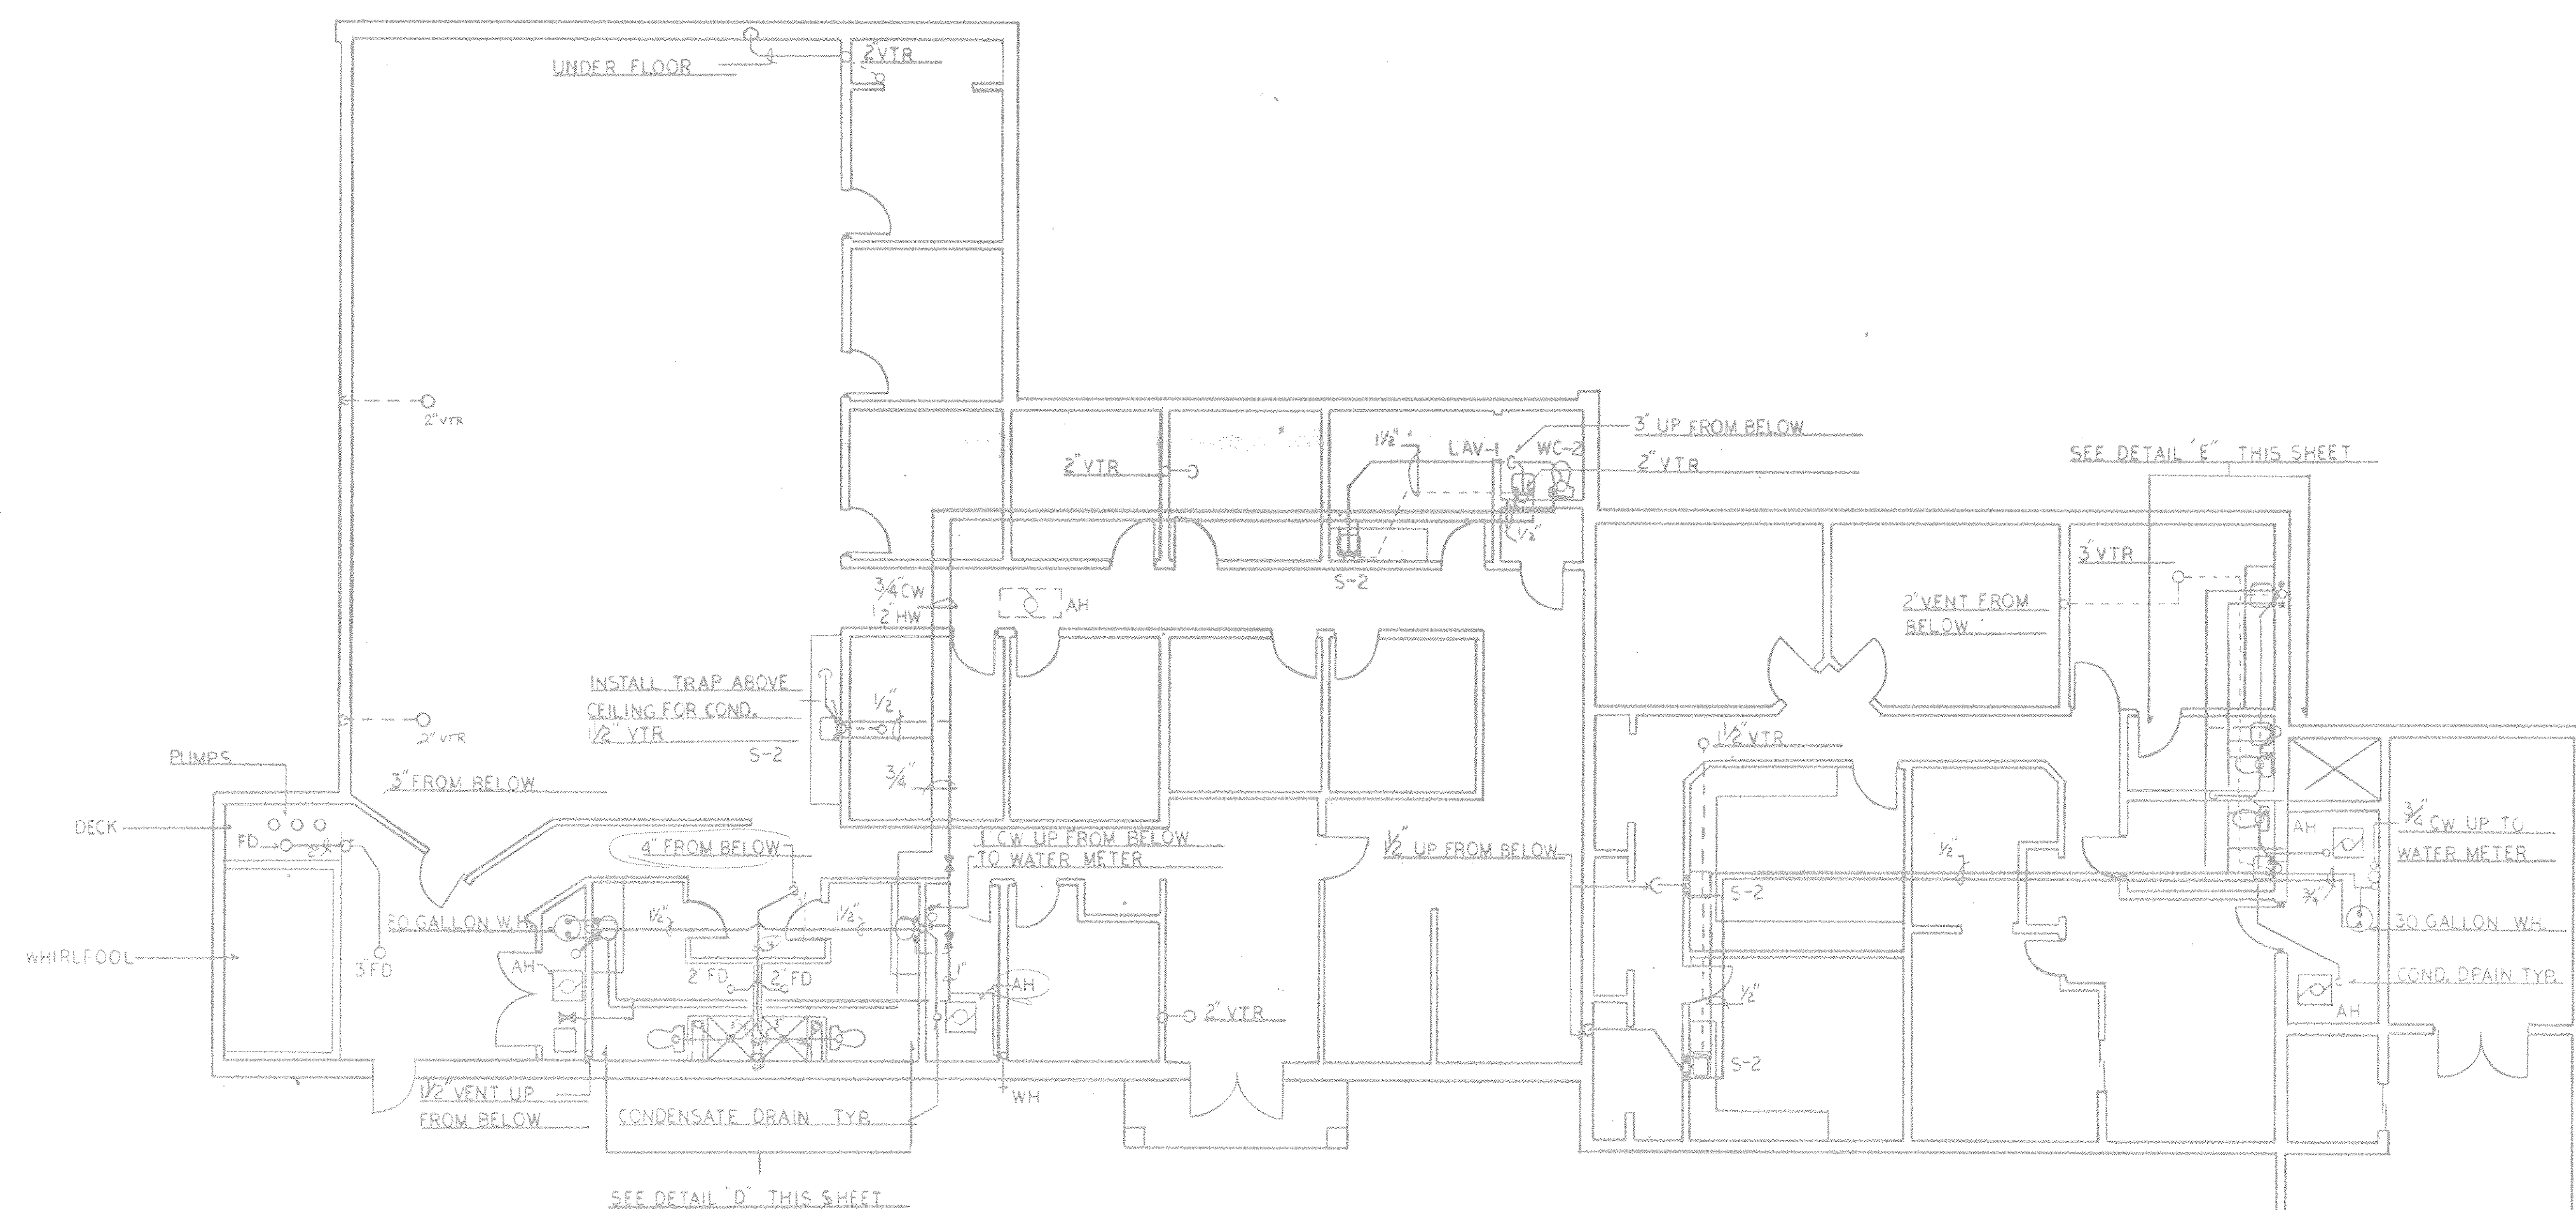

UPPER FLOOR PLAN 1/8" = 1'

PLUMBING NOTES

1. All connections to and from the photo processors shall be supplied and installed by others.
2. Coordinate layout of piping at each processor with the electrical and HVAC contractor.
3. Keep all piping out of the X-Ray rooms.
4. Drains for condensation shall be supplied where indicated on the drawings. Piping from the air handlers to the drains shall be supplied and installed by the HVAC contractor.
5. All horizontal and exposed water lines shall be insulated with 1/2" wall armaflex.

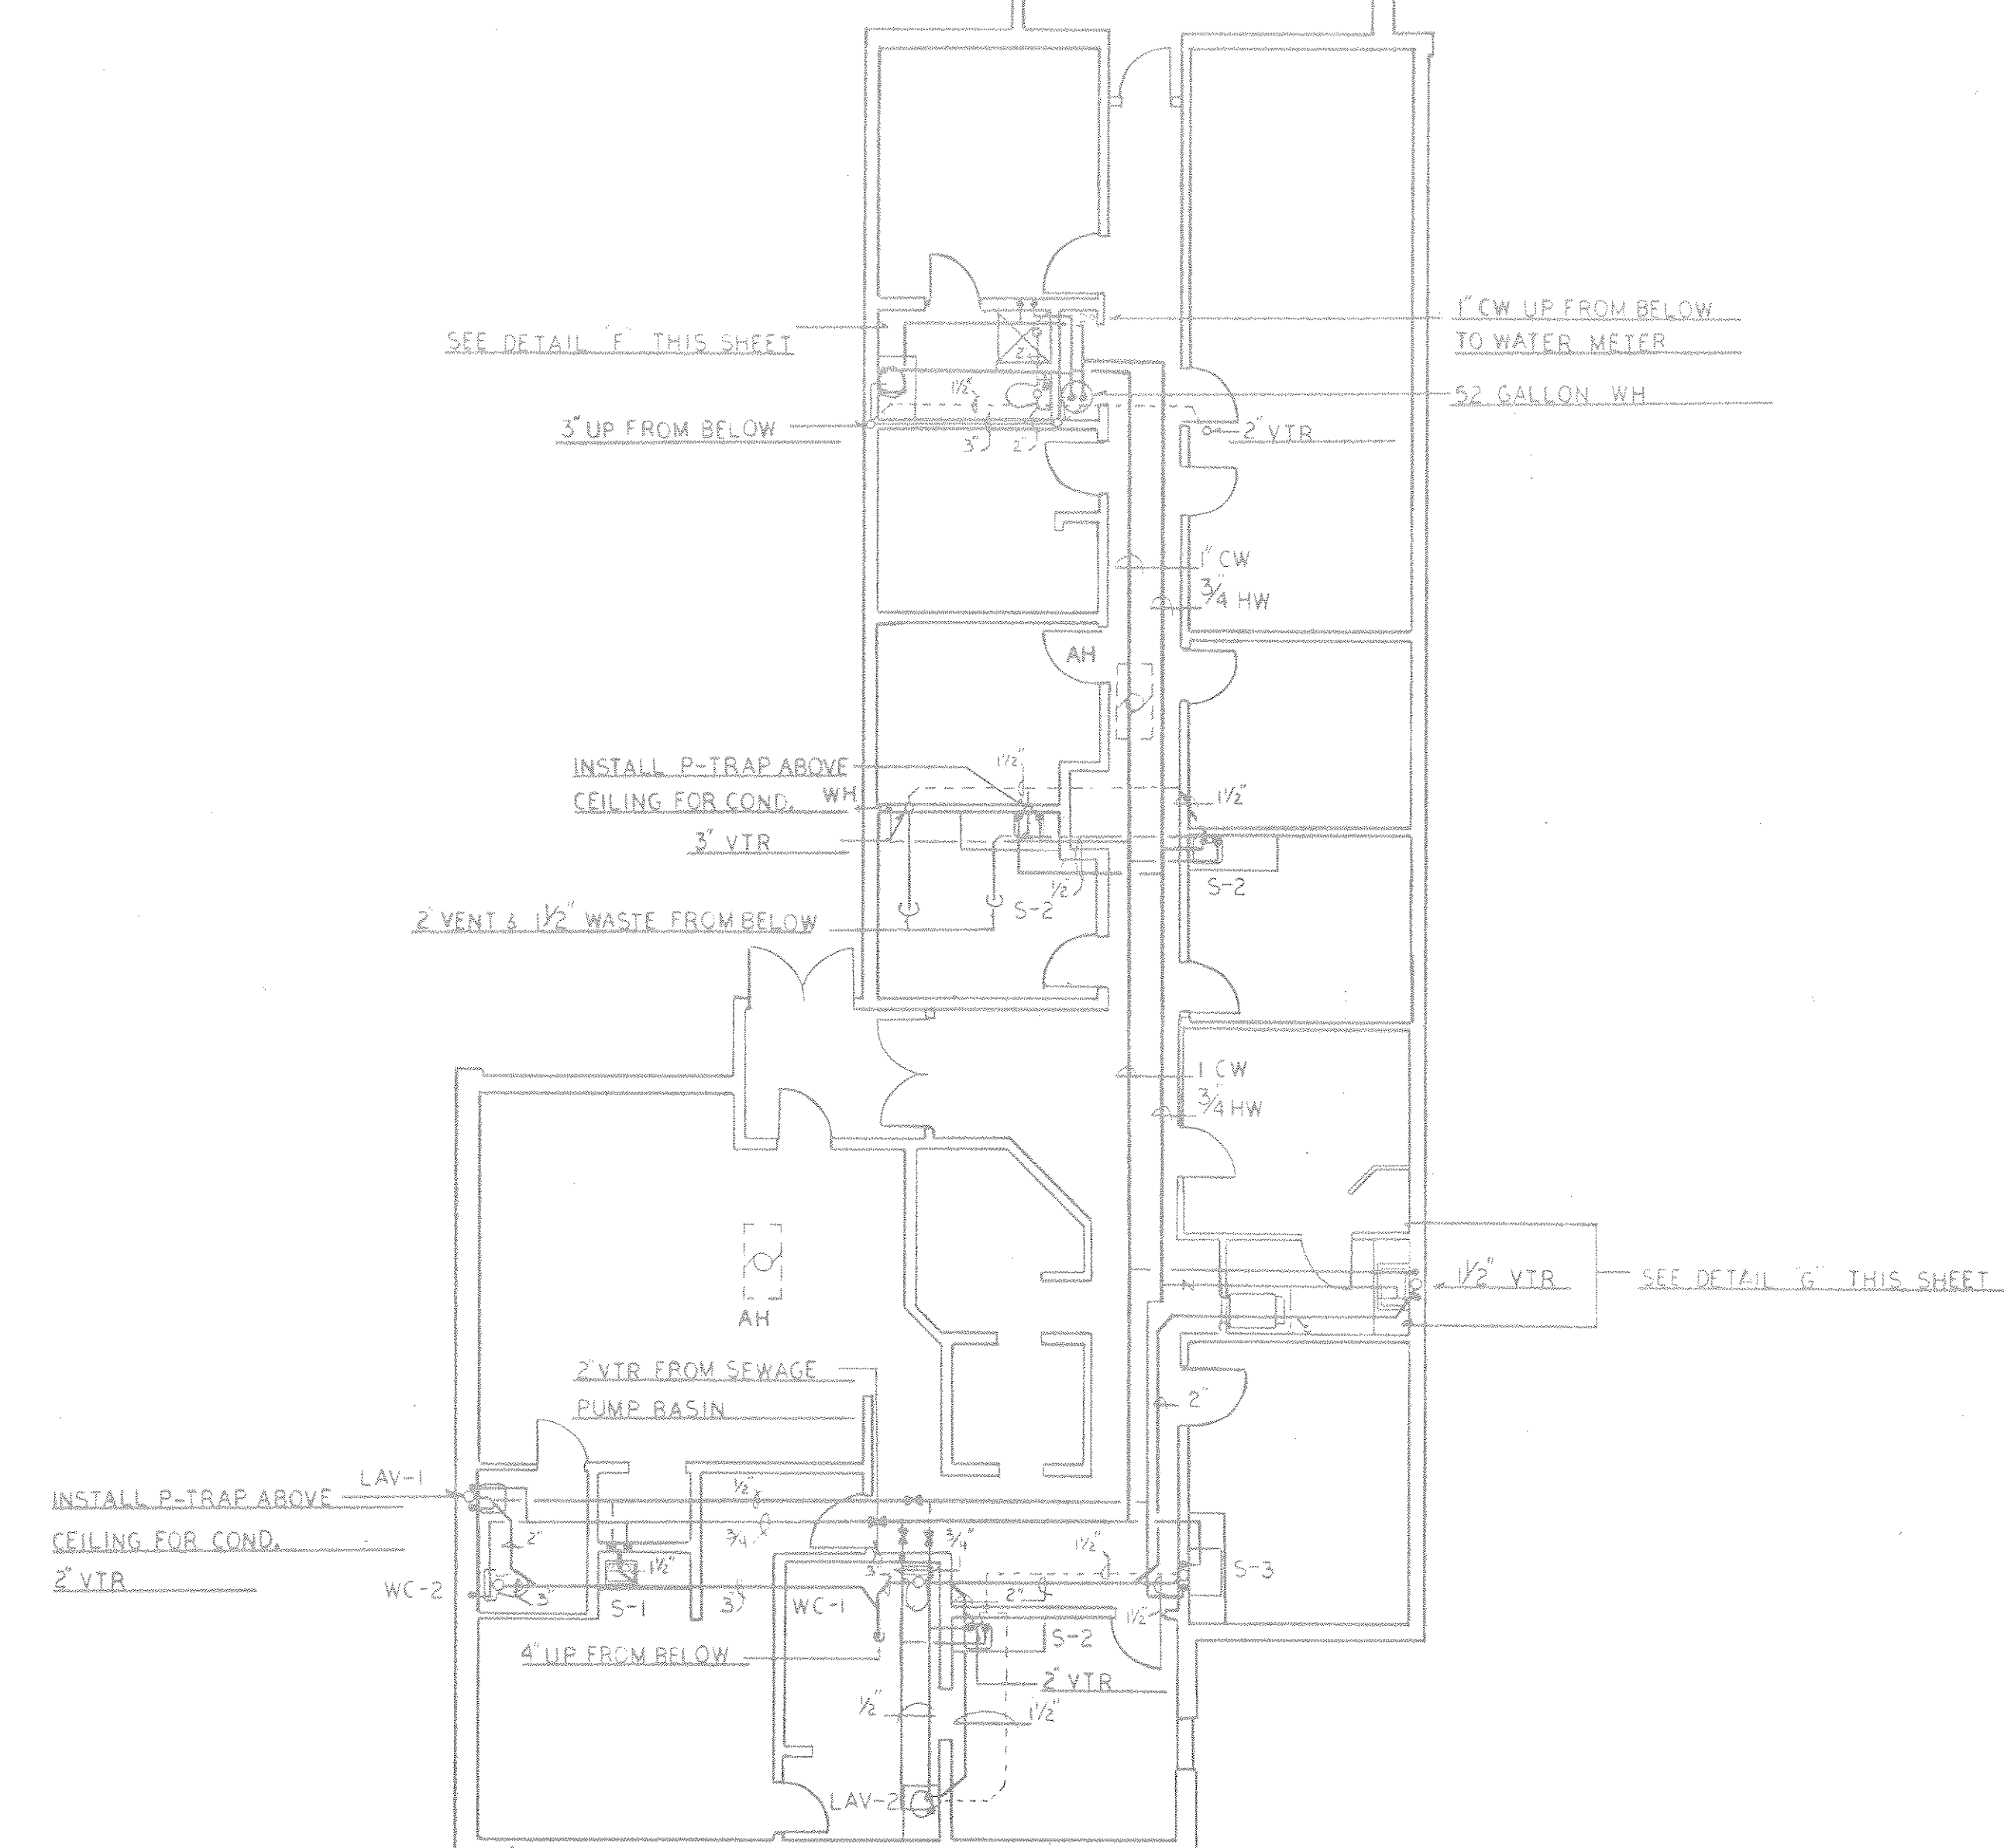REVISIONS

NO.	DATE			
-----	------	--	--	--


PROTECH

104 E. Prospect Road
Columbia, PA 17512
(717) 684-9050
FAX (717) 684-2595

NEW MEDICAL OFFICES
FOR
PHYSORTHORAD ASSO.
UPPER FLOOR
PLAN

DRAWING NO.

P-2

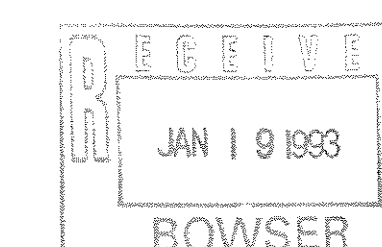



FIRST FLOOR PLAN


1/8" = 1'-0"

DRAWN	WM
CHECK	
DATE	11-5-92
SCALE	1/8"=1'-0"
JOB NO.	

DWG. NO. M-1

PHYSIORTHORAD ASSOCIATES
DERRY TOWNSHIP, PENNSYLVANIA


FIRST FLOOR MECHANICAL PLAN

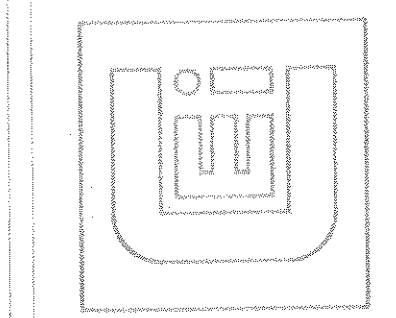

CLARK ELECTRIC INC.
REFRIGERATION - AIR CONDITIONING - ELECTRICAL - SHEET METAL
Pottsville, PA. 17562
Phone # (717) 687-7894

NO.	REVISIONS	DATE	BY

6/2/93
SHOP DRAWING

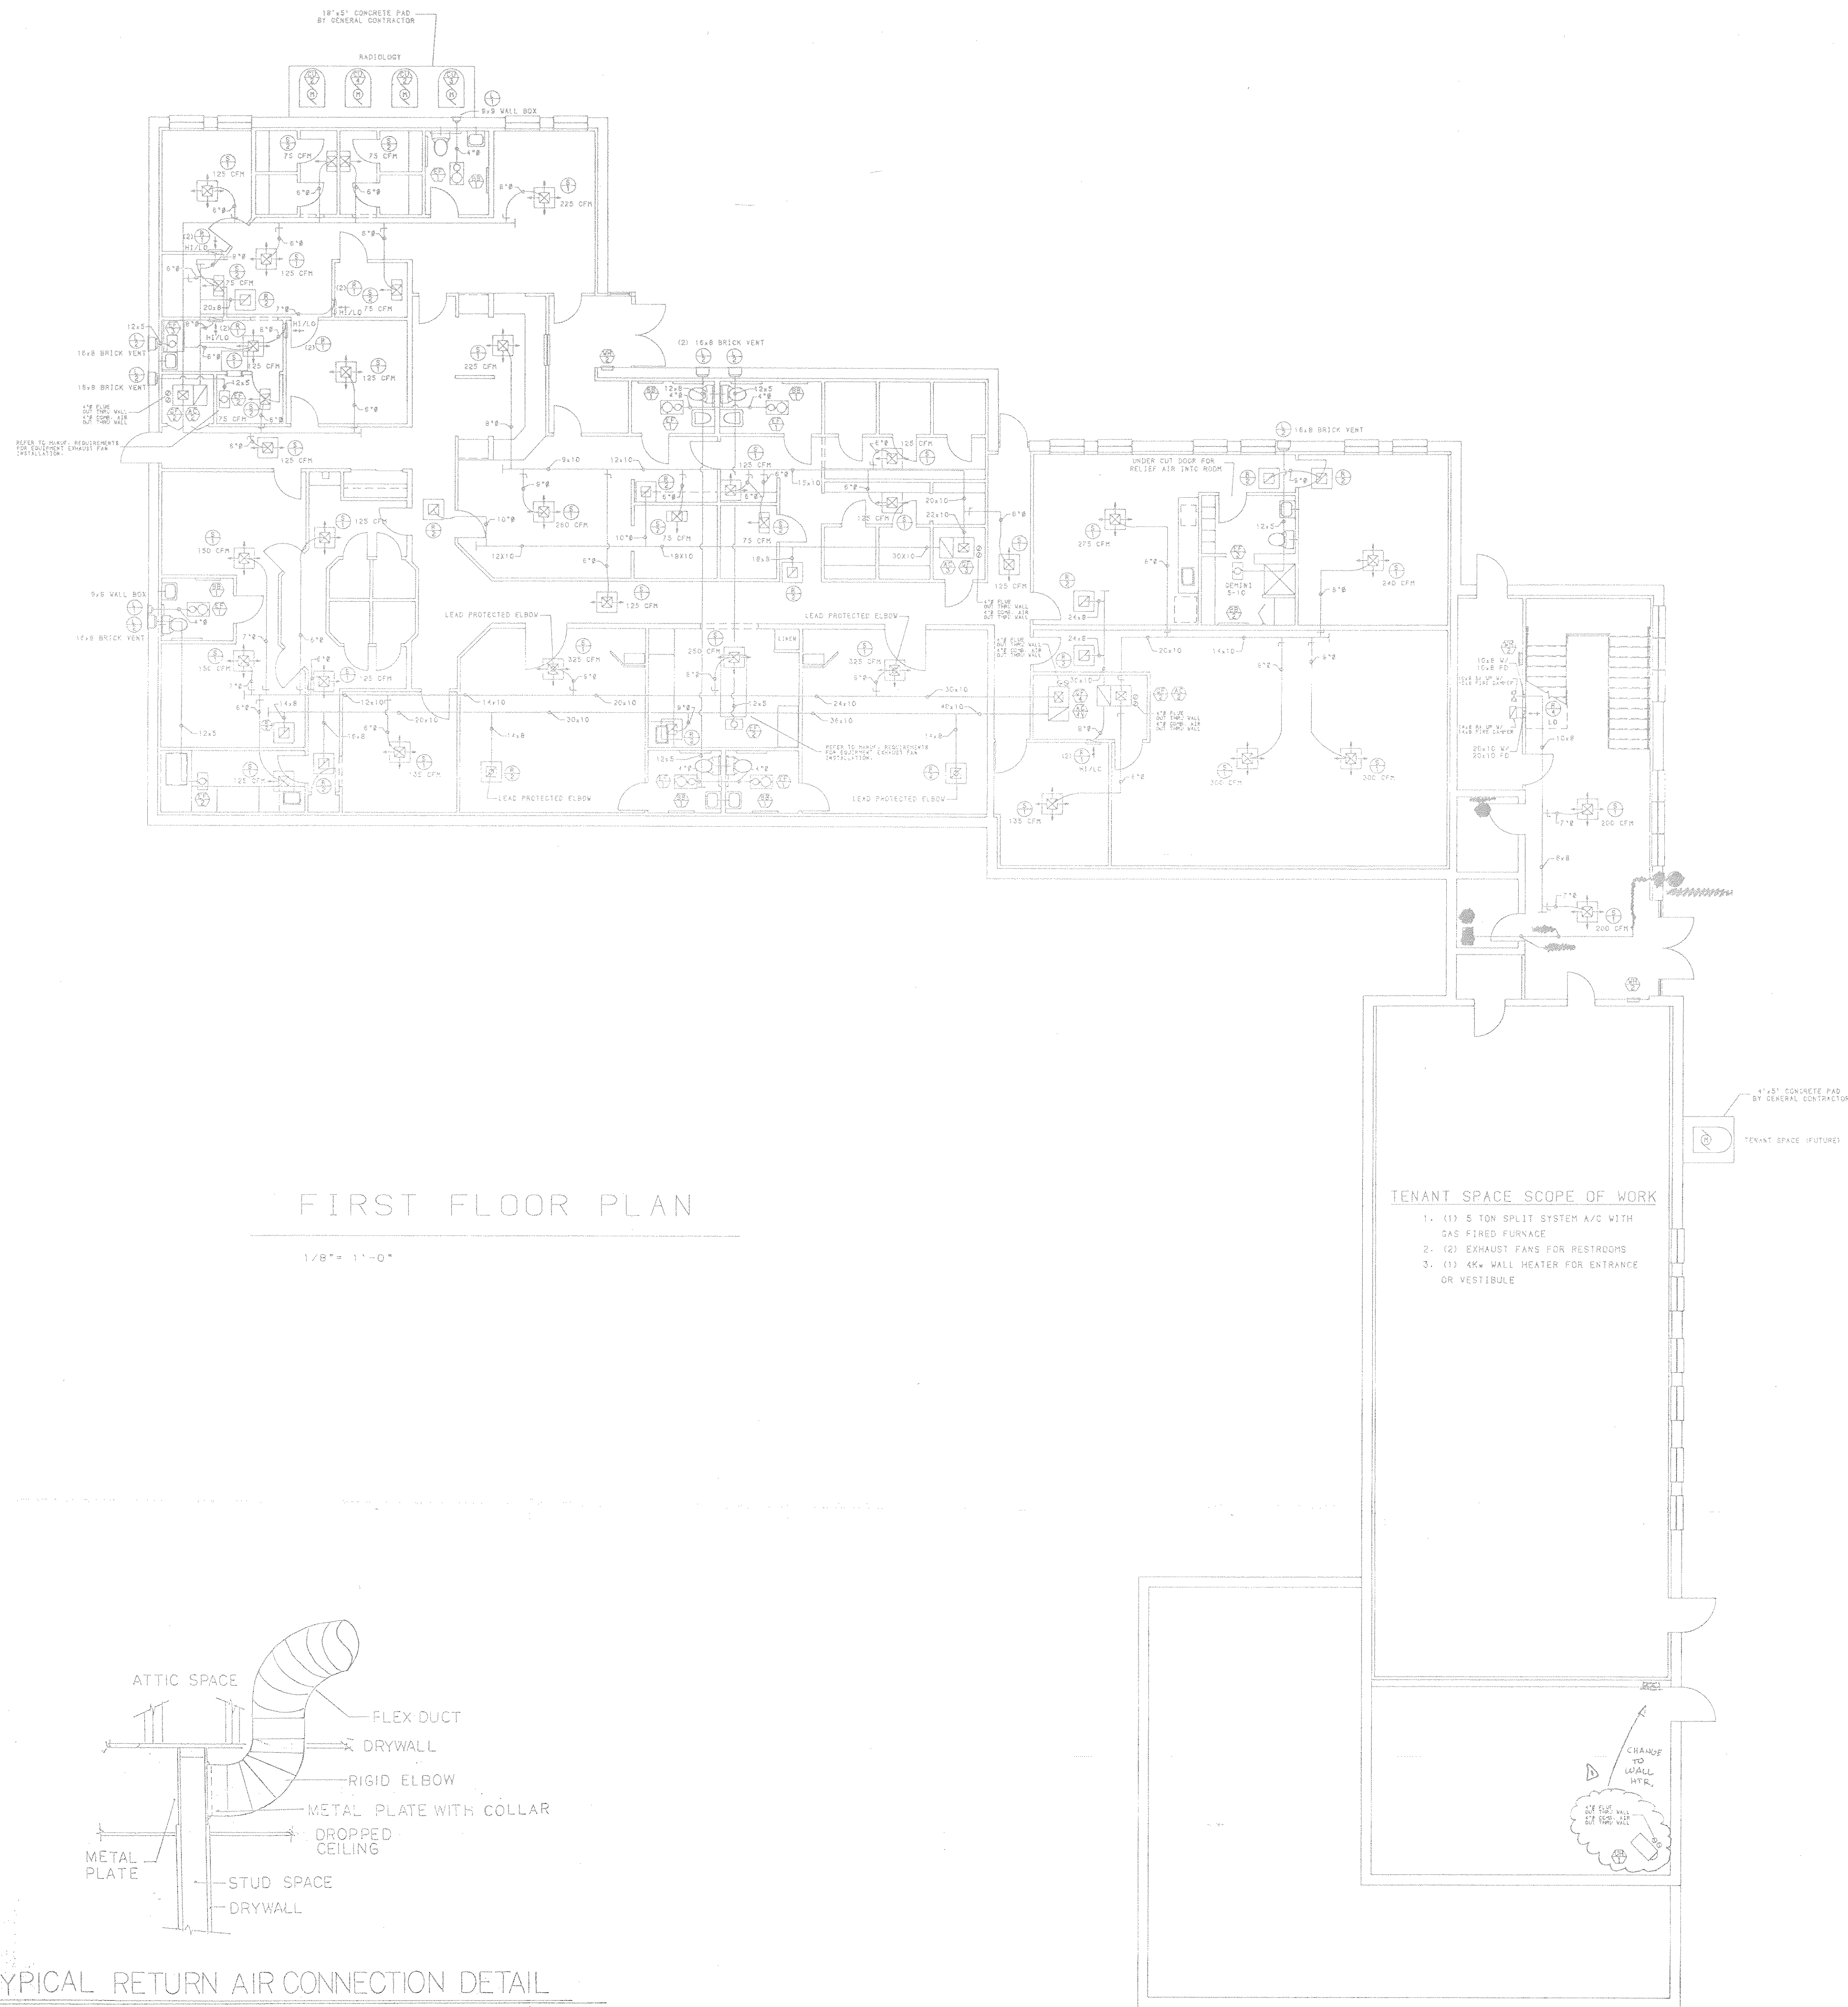

KEY	MANUFACTURER	MODEL #	NOMINAL CFM	NOMINAL TONS	MATCHED SEER	VOLTS	PHASE	O.C.
AC-1V	CARRIER	055A4030	900	2-1/2	10.0	208/1	1.5	25/2
CU-1	CARRIER	387A030-S01	-----	2-1/2	10.0	208/1	1.5	25/2
AC-2V	CARRIER	055A4036	1200	3	10.0	208/1	1.5	25/2
CU-2	CARRIER	387A036-S01	-----	3	10.0	208/1	1.5	25/2
AC-3V	CARRIER	055A4042	1375	3-1/2	10.2	208/1	1.5	40/2
CU-3	CARRIER	387A042-S01	-----	3-1/2	10.2	208/1	1.5	40/2
AC-4V	CARRIER	055A4048	1500	4	10.3	208/1	1.5	30/3
CU-4	CARRIER	387A048-S01	-----	4	10.3	208/1	1.5	30/3
AC-5V	CARRIER	055A4060	2125	5	10.3	208/1	1.5	35/2
CU-5	CARRIER	387A060-S01	-----	5	10.3	208/1	1.5	35/2

KEY	MANUFACTURER	MODEL #	NOMINAL CFM	NATURAL GAS	HP	FLA	O.C.
GF-1	CARRIER	583AC-0400G	1350	44.0	43.0	1/3	15/1
GF-2	CARRIER	583AC-0600G	1340	46.0	41.0	1/3	15/1
GF-3	CARRIER	583AC-0800G	1650	48.0	41.0	1/2	15/1
GF-4	CARRIER	583AC-1000G	2065	110.0	102.0	3/4	20/1
GF-5	CARRIER	583AC-1200G	1500	92.0	75.0	1/2	15/1
GF-6	CARRIER	583AC-0950G	1950	115.0	94.0	3/4	20/1
GF-7	CARRIER	583AC-1000G	2055	152.0	117.0	3/4	20/1

KEY	MANUFACTURER	MODEL #	NOMINAL CFM	NATURAL GAS	HP	FLA	O.C.
UH-1	REAR	11-25	180	25.0	24.0	1/30	1.5


KEY	MANUFACTURER	MODEL #	WATTS	MOUNT	VOLTS/PHASE	HP	O.C.	BTU/HRS
EH-1	CHROMOLA	QMS-7512-6A	500	BASEBOARD	120/1	4.2	15/1	1706
EH-2	CHROMOLA	QMS-7512M	750	BASEBOARD	120/1	6.2	15/1	2559
WH-1	CHROMOLA	AWH-4400-2	4,000	WALL	208/1	19.5	25/2	12,450
WH-2	CHROMOLA	AWH-4200-2	2,000	WALL	208/1	10	15/2	6,842

KEY	MANUFACTURER	MODEL #	SIZE	THROW	CFM	MOUNT	DESCRIPTION
S-1	CASCO	24X24	24" X 24"	6"	400	CEILING	4-WAY
S-2	CASCO	L14PC	12" X 24"	6"	200	CEILING	6-WAY
S-3	GRILLEMASTER	VH	20" X 8"	20"	400	WALL	1-WAY

KEY	MANUFACTURER	MODEL #	SIZE	CFM	MOUNT	DESCRIPTION
R-1	HART & COOLEY	650H	14" X 8"	175	WALL	RETURN
R-2	CASCO	24X24	24" X 24"	500	CEILING	RETURN
R-3	HART & COOLEY	650H	36" X 16"	1063	WALL	RETURN
R-4	HART & COOLEY	650H	24" X 12"	400	WALL	RETURN
R-5	HART & COOLEY	650H	24" X 24"	900	UNIT	RETURN

KEY	MANUFACTURER	MODEL #	CFM	S.P.	HP/WATTS	VOLTS/PHASE
EF-1	MUTONE	6684	70	---	50W	120/1
EF-2	GERING	4-15R	130	1/4"	63W	120/1
EF-3	GERING	5-10	210	1/4"	61W	120/1

CLARK ELECTRIC INC.
REFRIGERATION - AIR CONDITIONING - ELECTRICAL - SHEET METAL
Parsippany, NJ 07054
Phone # (973) 887-7676 Fax # (973) 887-9065

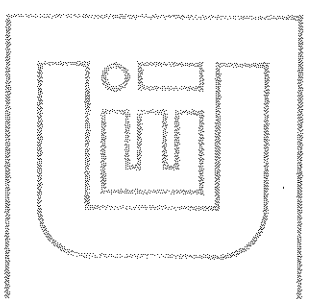

PHYSIORHOD ASSOCIATES
DERBY TOWNSHIP, PENNSYLVANIA
FIRST FLOOR MECHANICAL PLAN

DRAWN WM
CHECK
DATE 11-5-92
SCALE 1/8" = 1'-0"
JOB NO.

DWGNO. M-1

NOT FOR CONSTRUCTION
PRELIMINARY PENDING APPROVAL